
 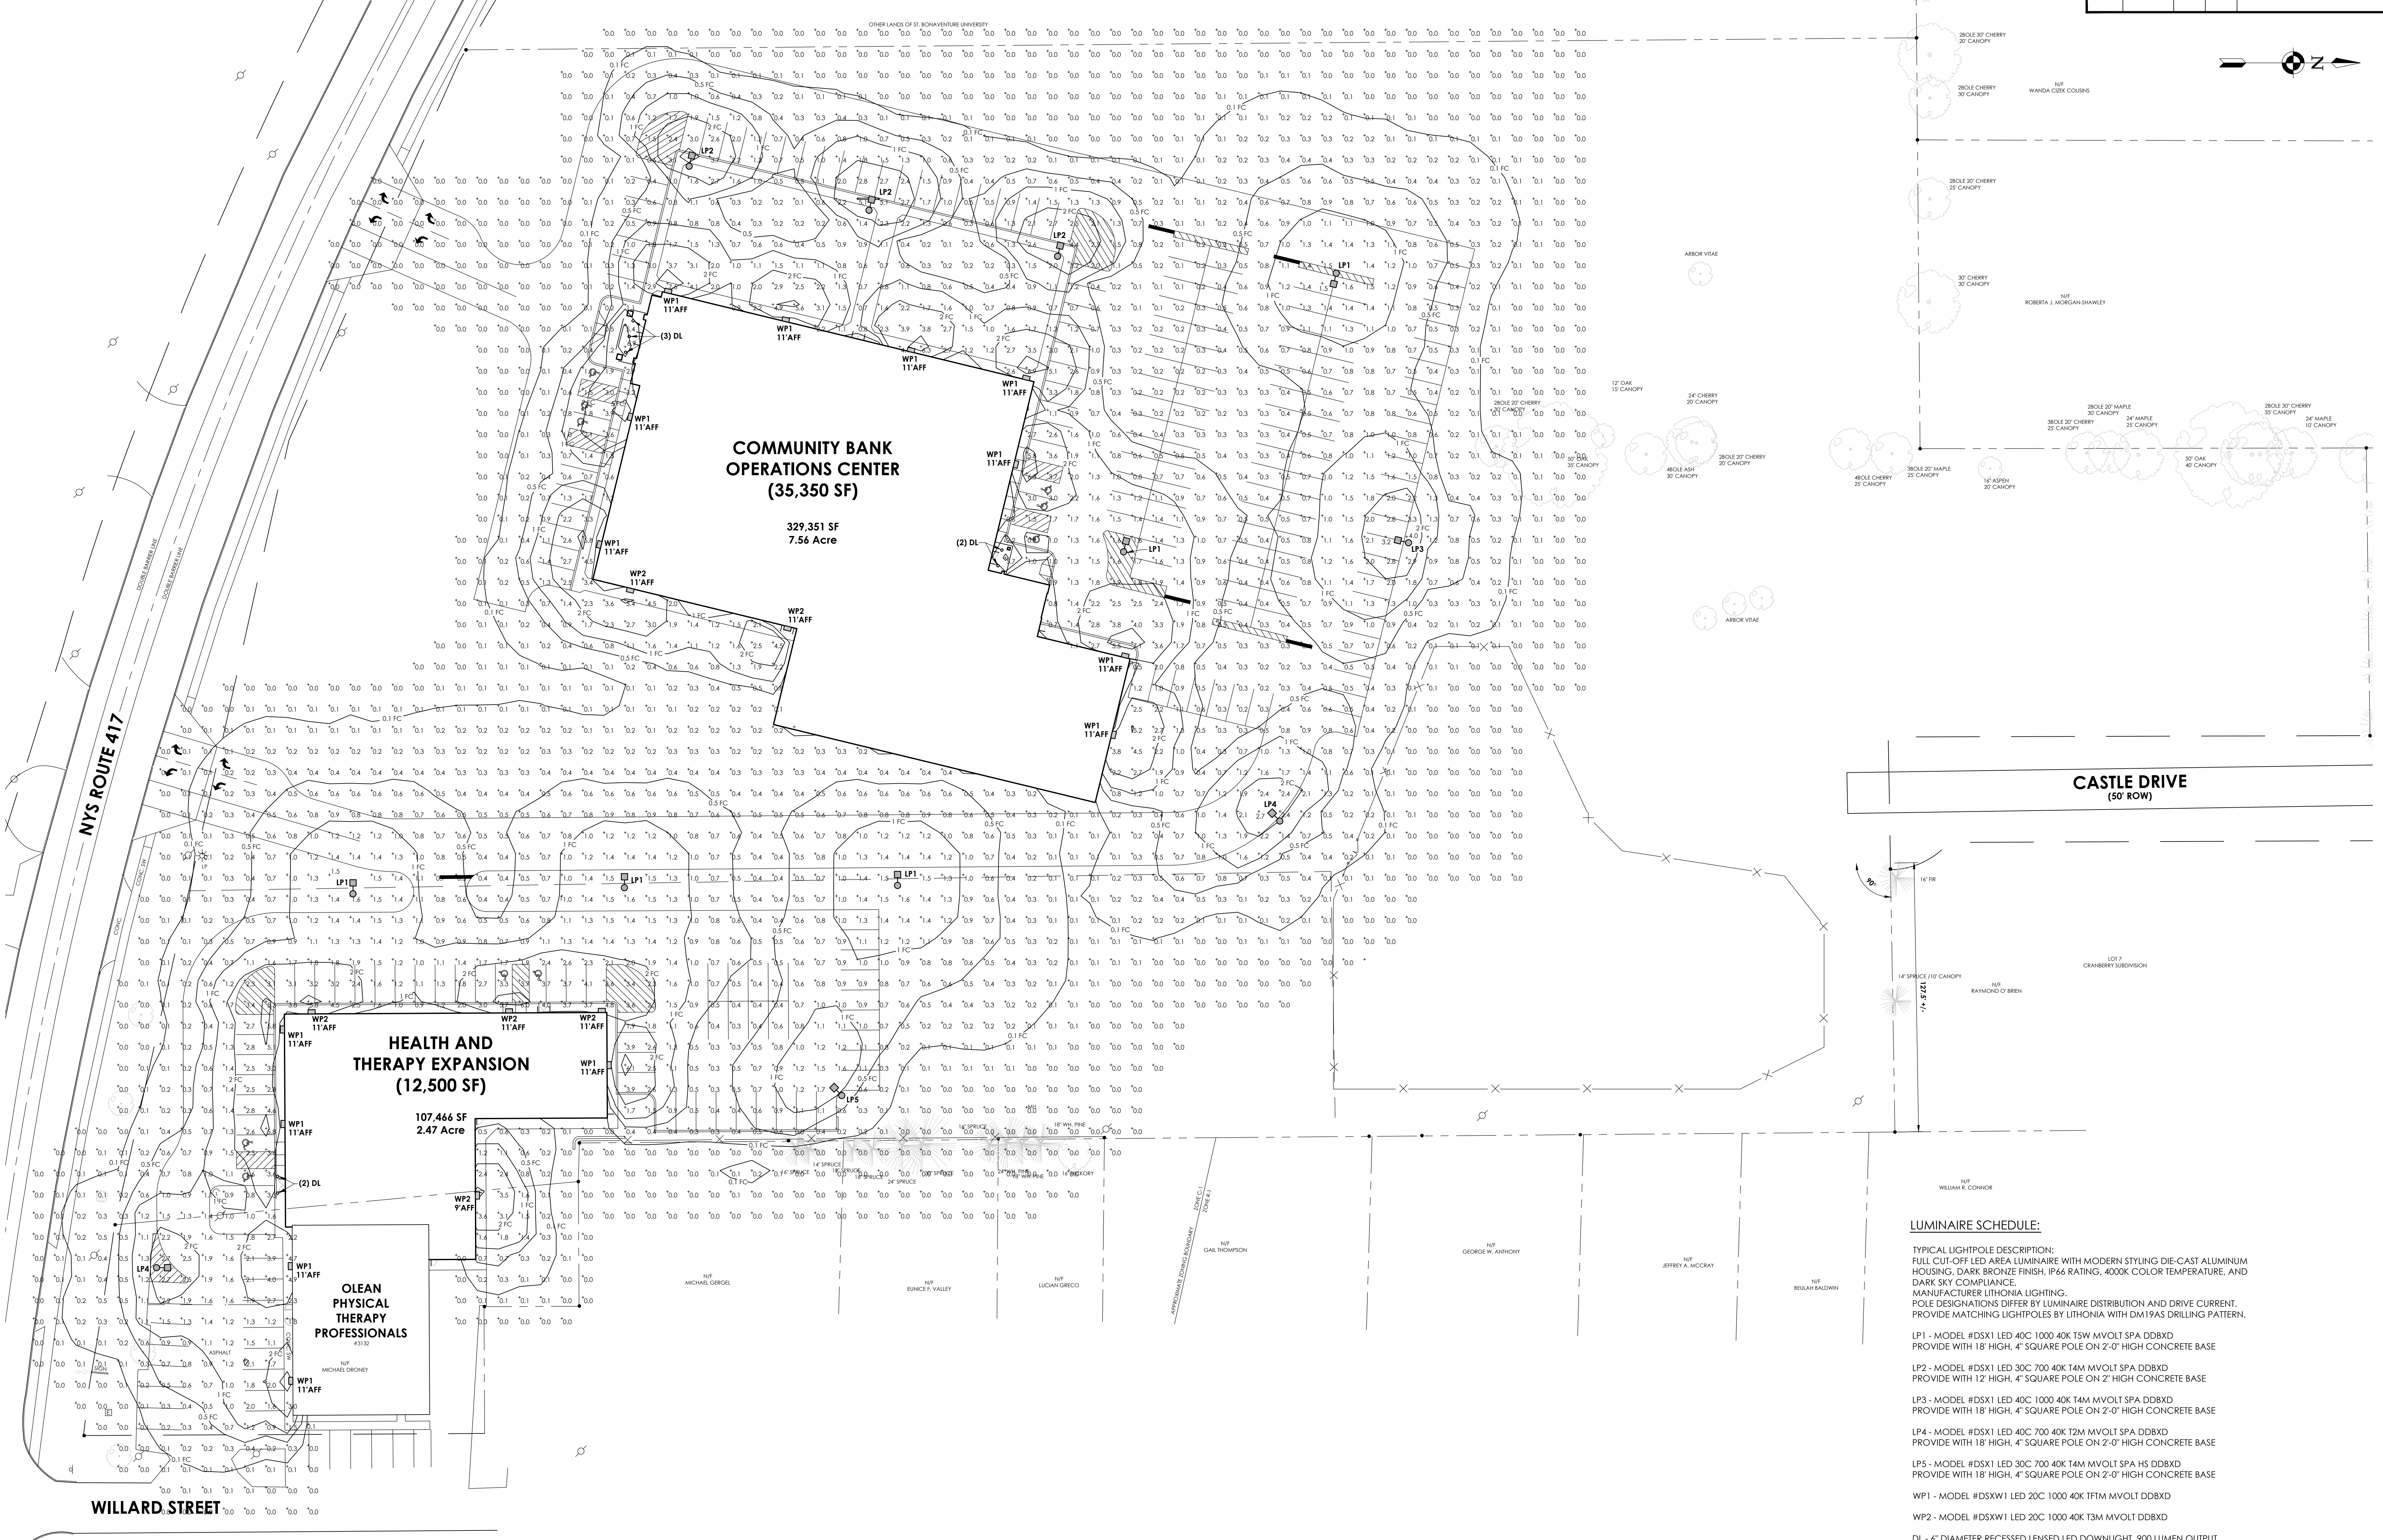


REVISIONS				
NO.	DATE	BY	CHKD	DESCRIPTION



**LUMINAIRE SCHEDULE:**

TYPICAL LIGHTPOLE DESCRIPTION:  
 FULL CUT-OFF LED AREA LUMINAIRE WITH MODERN STYLING DIE-CAST ALUMINUM HOUSING, DARK BRONZE FINISH, IP66 RATING, 4000K COLOR TEMPERATURE, AND DARK SKY COMPLIANCE.  
 MANUFACTURER: LITHONIA LIGHTING.  
 POLE DESIGNATIONS DIFFER BY LUMINAIRE DISTRIBUTION AND DRIVE CURRENT. PROVIDE MATCHING LIGHTPOLES BY LITHONIA WITH DM19AS DRILLING PATTERN.

LP1 - MODEL #DSX1 LED 40C 1000 40K 15W MVOLT SPA DBBXD  
 PROVIDE WITH 18" HIGH, 4" SQUARE POLE ON 2'-0" HIGH CONCRETE BASE

LP2 - MODEL #DSX1 LED 30C 700 40K 14M MVOLT SPA DBBXD  
 PROVIDE WITH 12" HIGH, 4" SQUARE POLE ON 2'-0" HIGH CONCRETE BASE

LP3 - MODEL #DSX1 LED 40C 1000 40K 14M MVOLT SPA DBBXD  
 PROVIDE WITH 18" HIGH, 4" SQUARE POLE ON 2'-0" HIGH CONCRETE BASE

LP4 - MODEL #DSX1 LED 40C 700 40K 12M MVOLT SPA DBBXD  
 PROVIDE WITH 18" HIGH, 4" SQUARE POLE ON 2'-0" HIGH CONCRETE BASE

LP5 - MODEL #DSX1 LED 30C 700 40K 14M MVOLT SPA HS DBBXD  
 PROVIDE WITH 18" HIGH, 4" SQUARE POLE ON 2'-0" HIGH CONCRETE BASE

WP1 - MODEL #DSXW1 LED 20C 1000 40K 11M MVOLT DBBXD

WP2 - MODEL #DSXW1 LED 20C 1000 40K 13M MVOLT DBBXD

DL - 6" DIAMETER RECESSED LENSED LED DOWNLIGHT, 900 LUMEN OUTPUT

**COMMUNITY BANK OPERATIONS CENTER & OLEAN PHYSICAL THERAPY EXPANSION  
 SITE LIGHTING PLAN**

SCALE: 1"=30'  
 MAY 2, 2014