


Friday, February 24, 2017 - 7:59am EST B:\2017\085\17336\DAVE KAZMIERCZAK\16336 PARKING LOT DESIGN.dwg

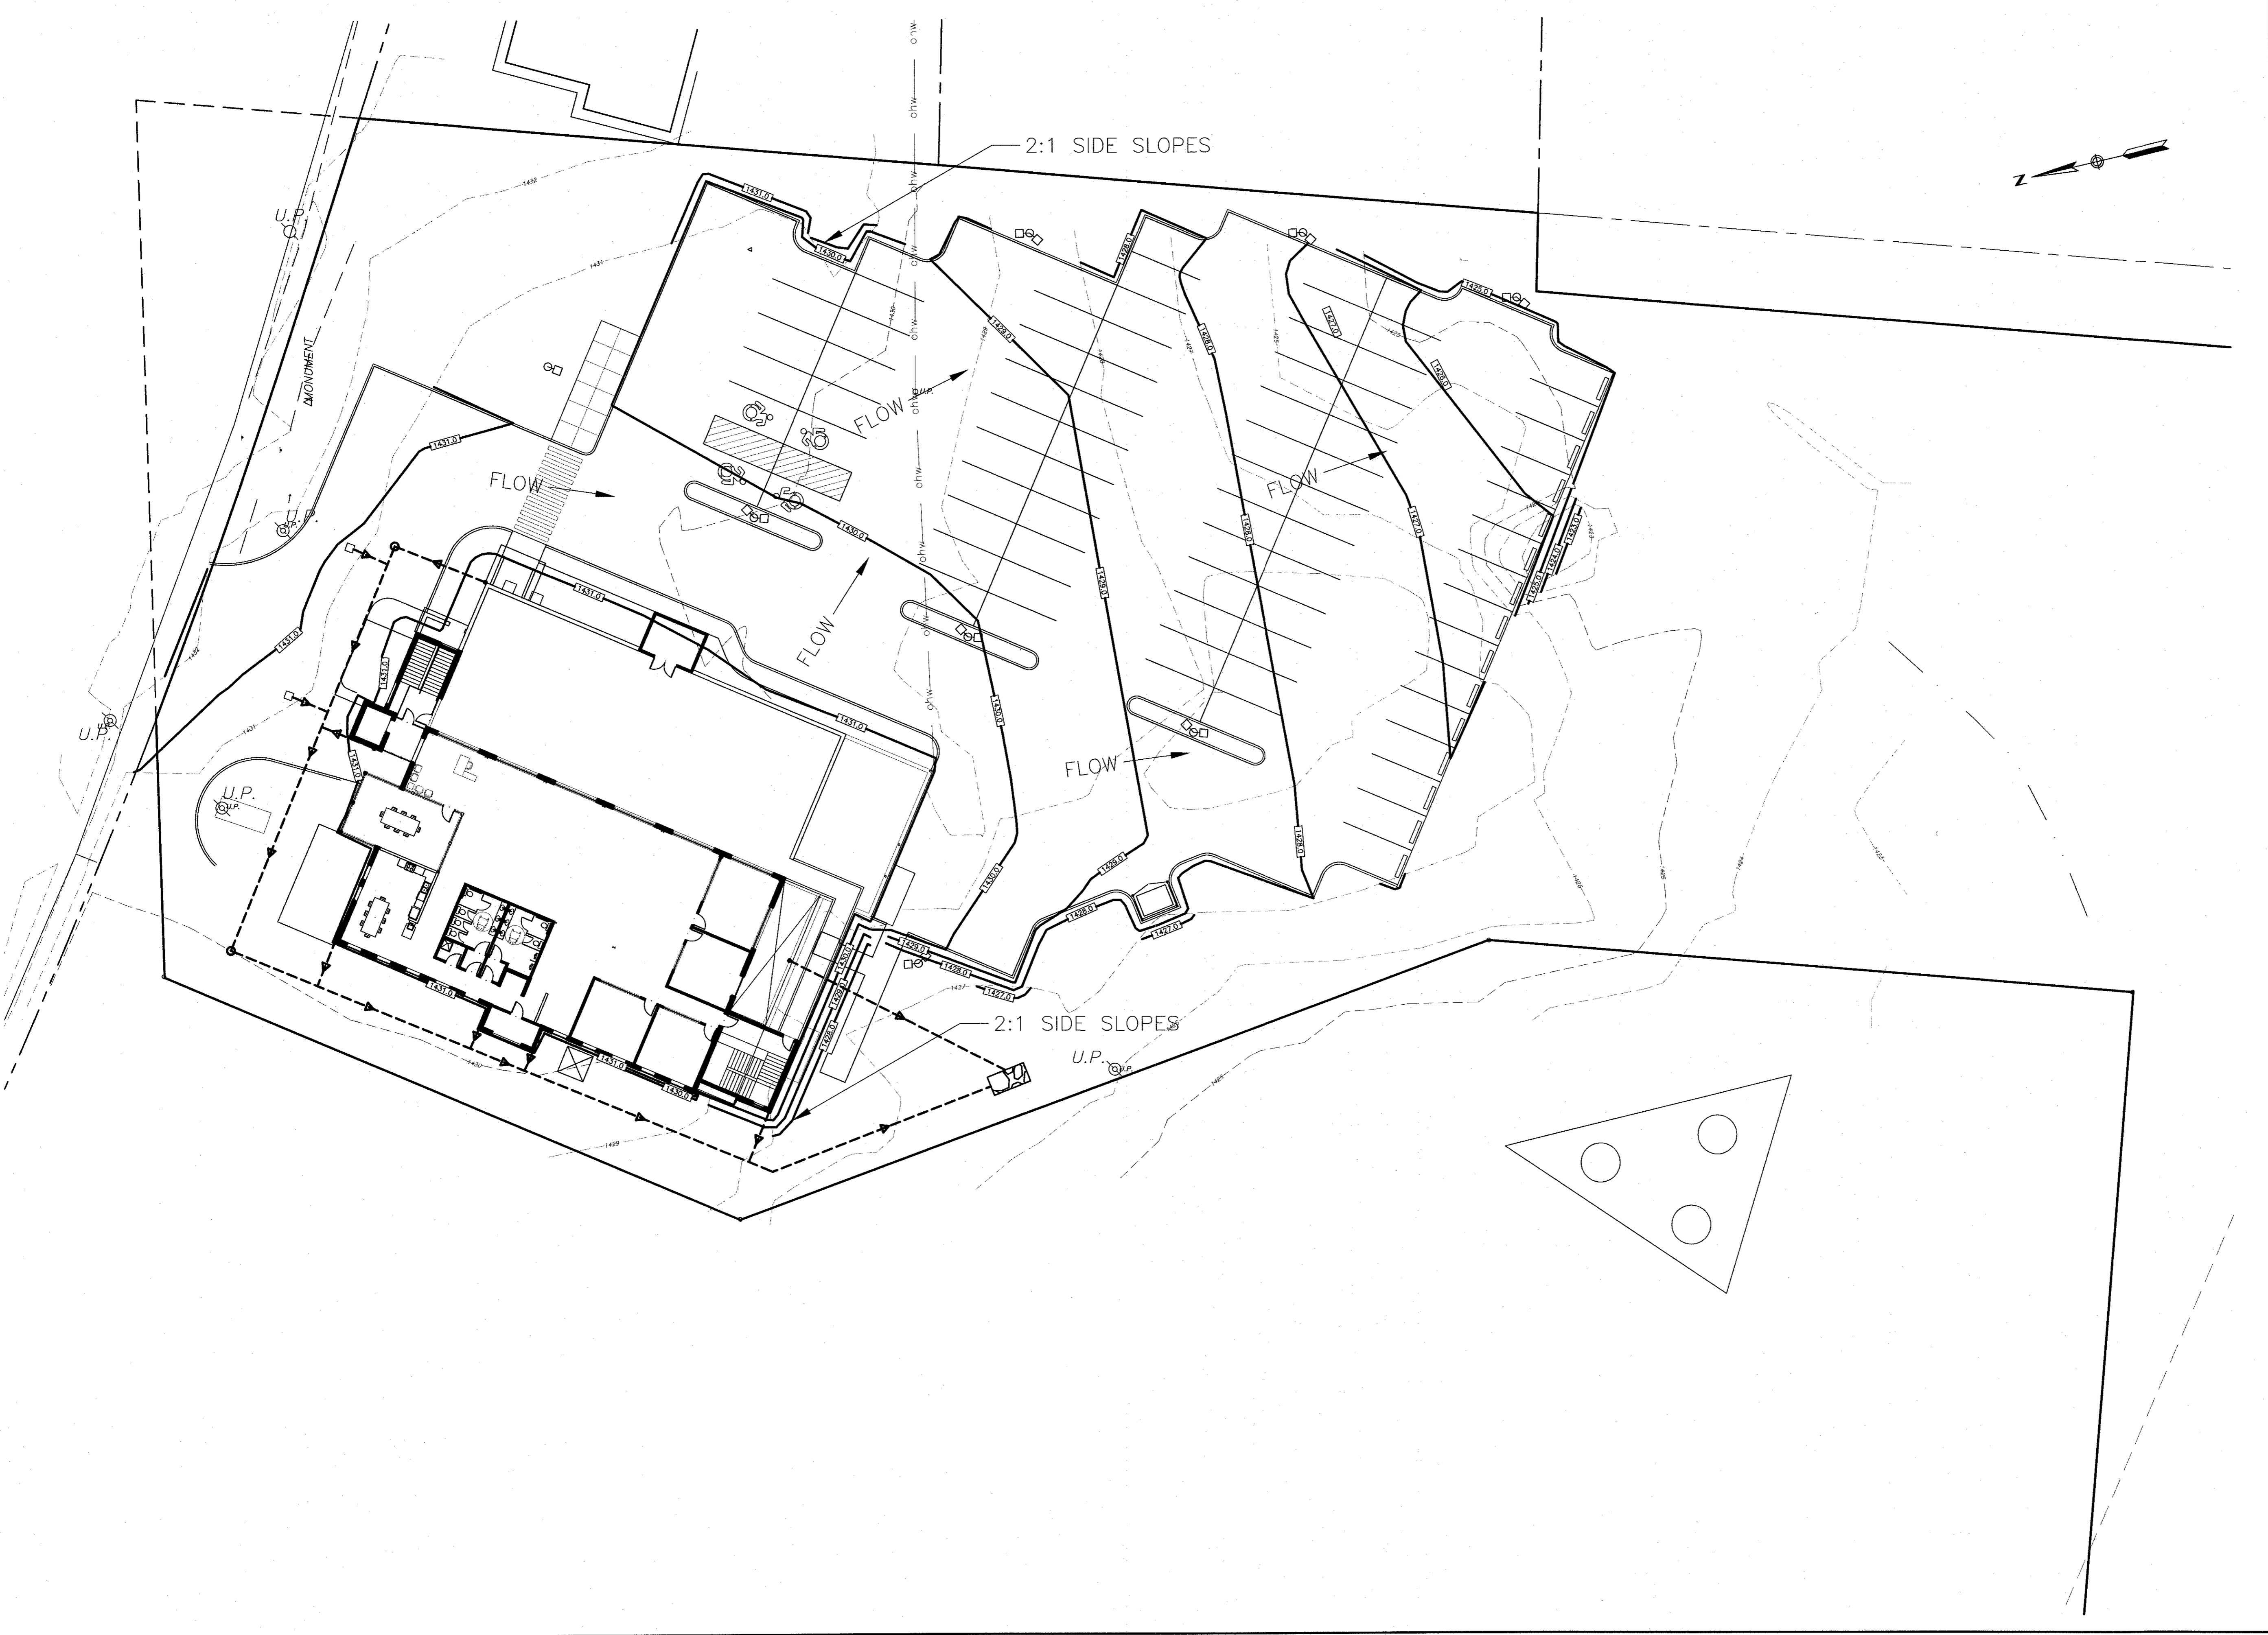


E&M

Engineers and Surveyors PC

SERVING PENNSYLVANIA AND NEW YORK SINCE 1946

24 DERRICK ROAD
BRADFORD, PENNSYLVANIA 16701
TELEPHONE: (814) 362-5546
FAX: (814) 362-3023
www.emengineers.com

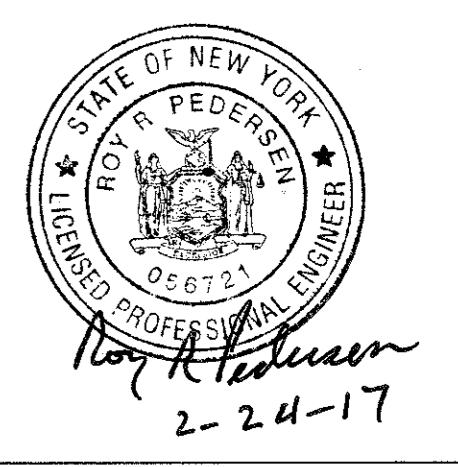

REVISIONS		
No.	DATE	DESCRIPTION

Copyright : E&M Engineers & Surveyors, P.C. 2007.
ANY ALTERATION OF THIS DOCUMENT SHALL CONFORM TO THE EDUCATION LAW.

DAVID KAZMIERCZAK
567 EXCHANGE ST. SUITE 403
BUFFALO, NY 14210
CLIENT TELEPHONE: (716) 855-2225

3153 WEST STATE STREET
ALLEGANY, NY

DRAINAGE PLAN


TOWN OF ALLEGANY
CATTARAUGUS COUNTY
NEW YORK



SCALE: 1" = 20'	
DESIGNED BY: RP	JOB NO. 17336
DRAWN BY: RER	TASK NO. T-01
CHECKED BY: RP	DATE: 02/23/2017
FILE NO. B2017-1	SHEET 1 OF 2

SERVING
PENNSYLVANIA
AND NEW YORK
SINCE 1946

24 DERRICK ROAD
BRADFORD, PENNSYLVANIA 16701
TELEPHONE: (814) 362-5546
FAX: (814) 362-3023
www.emengineers.com

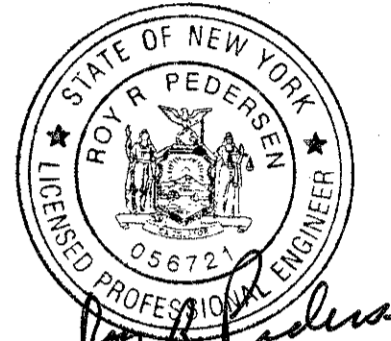

David Kazmierczak
2/24/17


REVISIONS		
No.	DATE	DESCRIPTION

Copyright : E&M Engineers & Surveyors, P.C. 2007
ANY ALTERATION OF THIS DOCUMENT SHALL CONFORM TO THE EDUCATION LAW.


DAVID KAZMIERCZAK
567 EXCHANGE ST. SUITE 403
BUFFALO, NY 14210
CLIENT TELEPHONE: (716) 855-2225

DRAINAGE PLAN

 TOWN OF ALLEGANY
CATTARAUGUS COUNTY
NEW YORK



SCALE: 1" = 10'	DESIGNED BY: RP	JOB NO. 17336
DRAWN BY: RER	CHECKED BY: RP	TASK NO. T-01
FILE NO. B2017-1	DATE: 02/23/2017	SHEET 2 OF 2

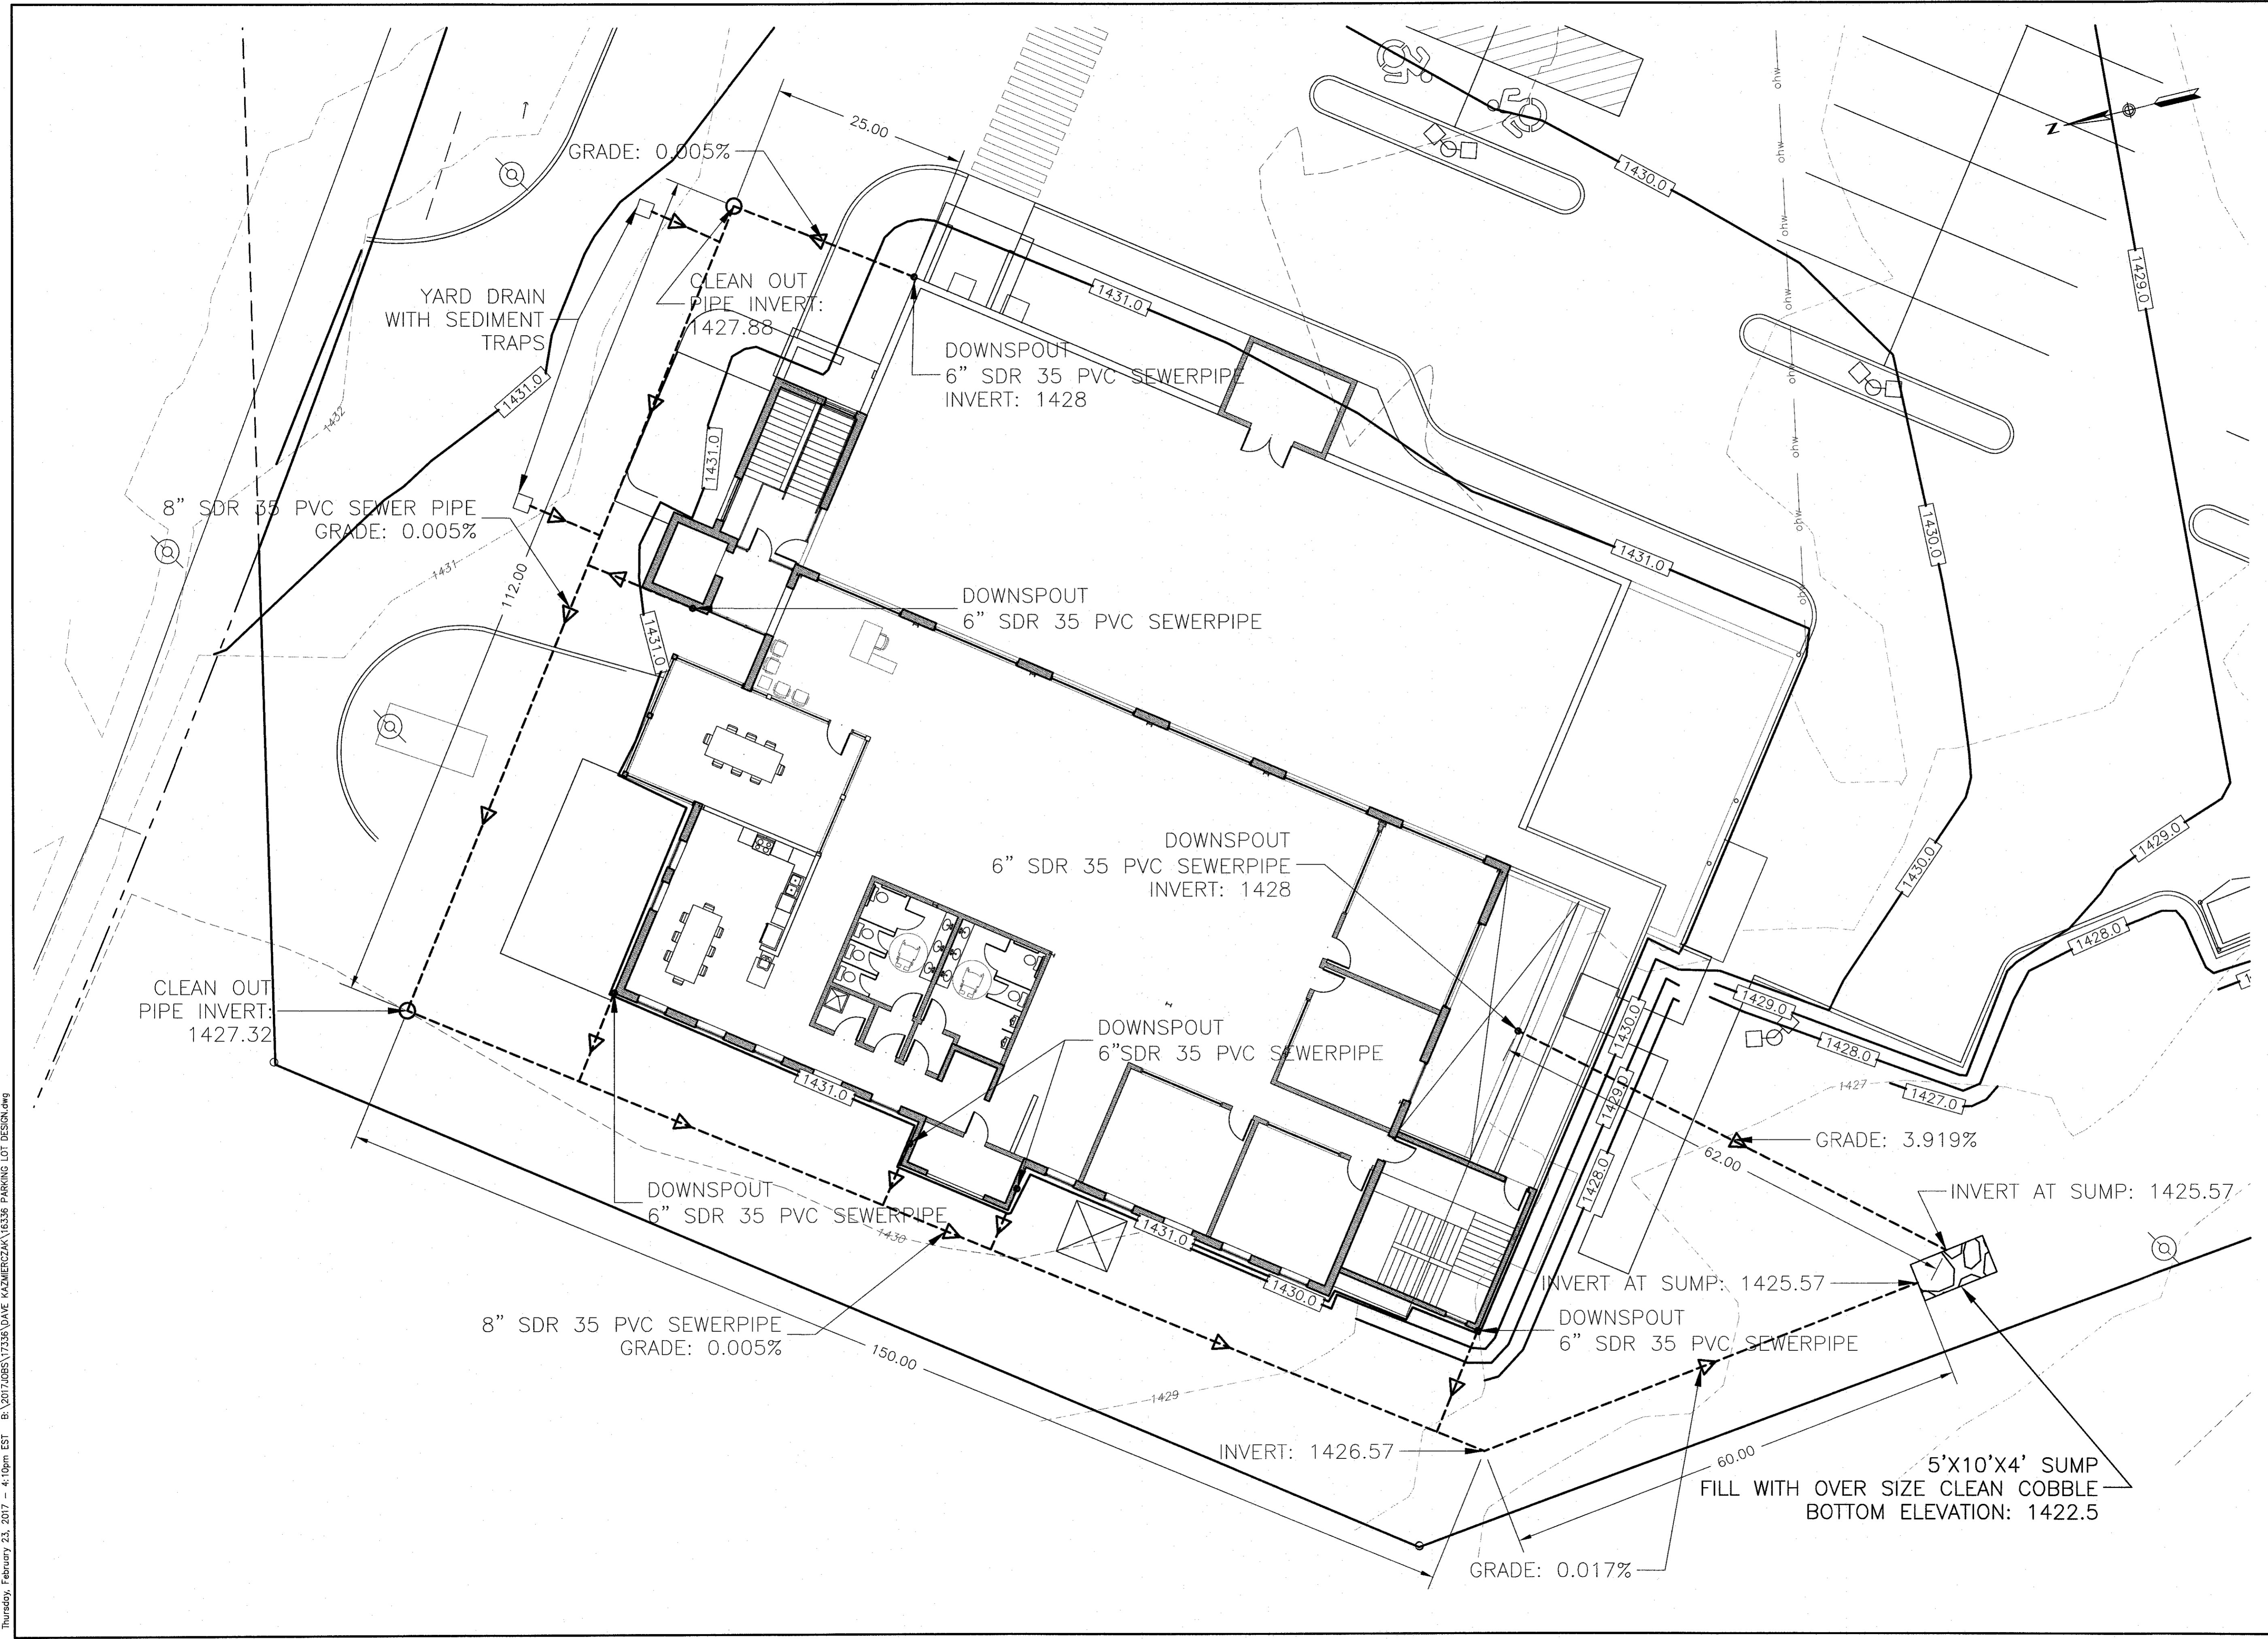

Thursday, February 23, 2017 - 4:10pm EST B:\2017\0085\17336\DAVE KAZMIERCZAK\16536 PARKING LOT DESIGN.dwg